

Maharashtra University of Health Sciences, Nashik

**Trust Deed / Bylaws/ Registration Certificate
(Trust / Hospital (Bombay Nursing Act))**

Faculty :- Ayurved


Name of College :- K. G. Mittal Ayurved College, Mumbai 400 002

Name of Trust / Society	Mittal Foundation Trust
Registration Certificate	Trust / Society :- Hospital (Bombay Nursing Act) :- 1949
Name of the College / Institute (As per First Affiliation letter)	: K. G. Mittal Ayurved College
Address	: Netaji Subhash Road, Marine Drive, Next to Taraporewala Aquarium, Mumbai- 400 002.
Email ID	: kgmpacollege@gmail.com
Telephone / Mobile No.(s)	: 022-69088000
Website	: https://www.kgmittalayurvedcollege.com
College Code	: 3102



Dean/ Principal Stamp & Signature

INCHARGE PRINCIPAL
K. G. Mittal Ayurved College
Netaji Subhash Road, Marine Drive,
Next to Taraporewala Aquarium,
Mumbai - 400 002.

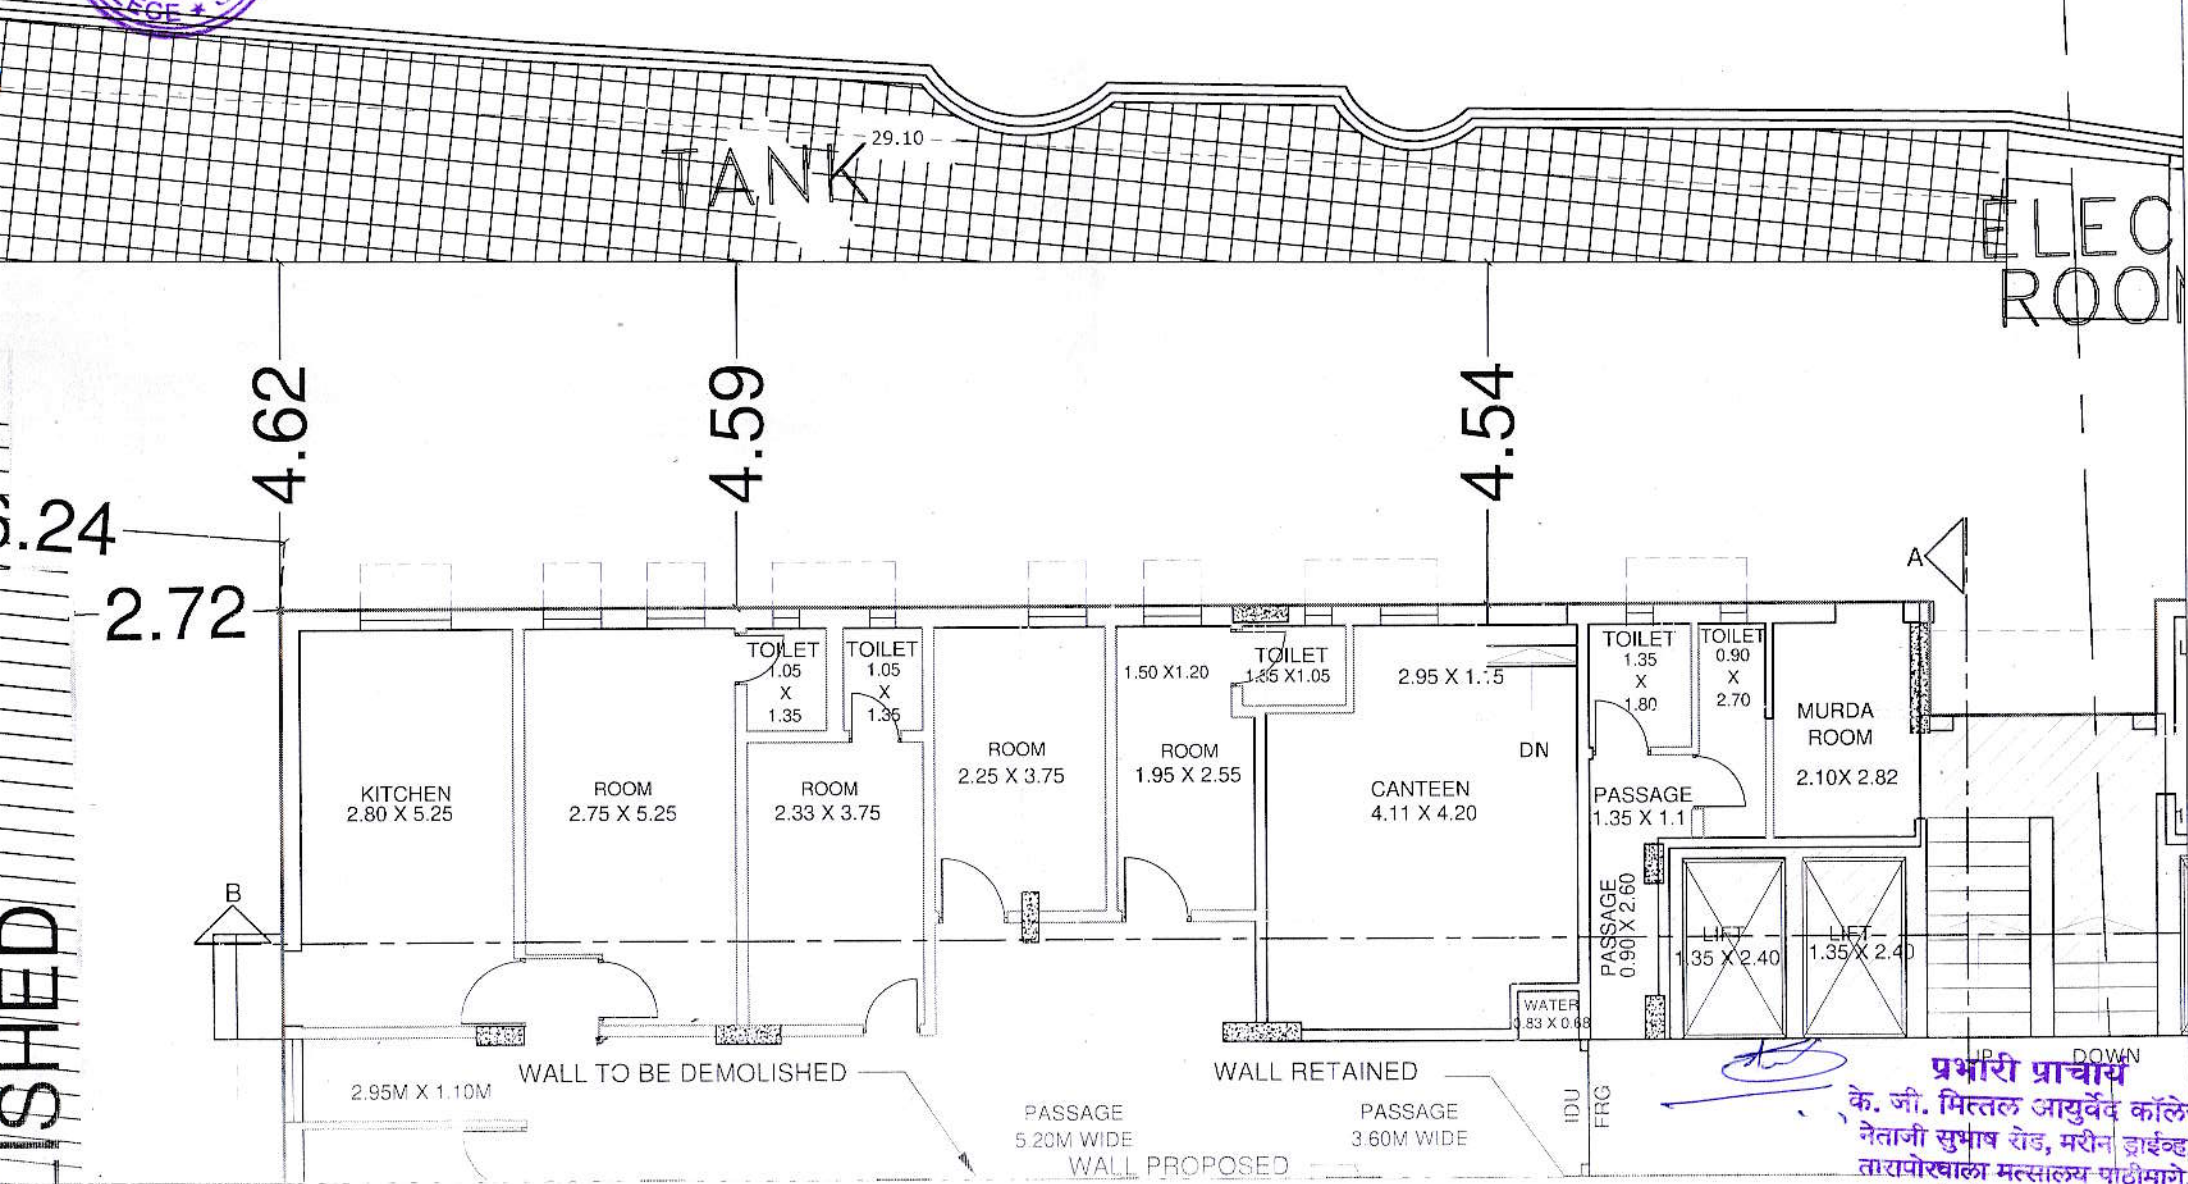

6.24
2.72
SHED

4.62

4.59

4.54

29.10

TANK

ELEC ROOM

KITCHEN
2.80 X 5.25

ROOM
2.75 X 5.25

ROOM
2.33 X 3.75

ROOM
2.25 X 3.75

ROOM
1.95 X 2.55

CANTEN
4.11 X 4.20

PASSAGE
1.35 X 1.1

MURDA ROOM
2.10 X 2.82

2.95M X 1.10M

WALL TO BE DEMOLISHED

PASSAGE
5.20M WIDE

WALL PROPOSED

WALL RETAINED

PASSAGE
3.60M WIDE

WATER
0.83 X 0.68


PASSAGE
0.90 X 2.60

LIFT
1.35 X 2.40

LIFT
1.35 X 2.40

IDU
FRG


UP DOWN
प्रभारी प्राचार्य
के. जी. मित्तल आयुर्वेद कॉलेज
नेताजी सुभाष रोड, मरीन ड्राईव्ह,
तारापोरवाला मत्सालय फाटीमागे,
मुंबई - ४०० ००२.

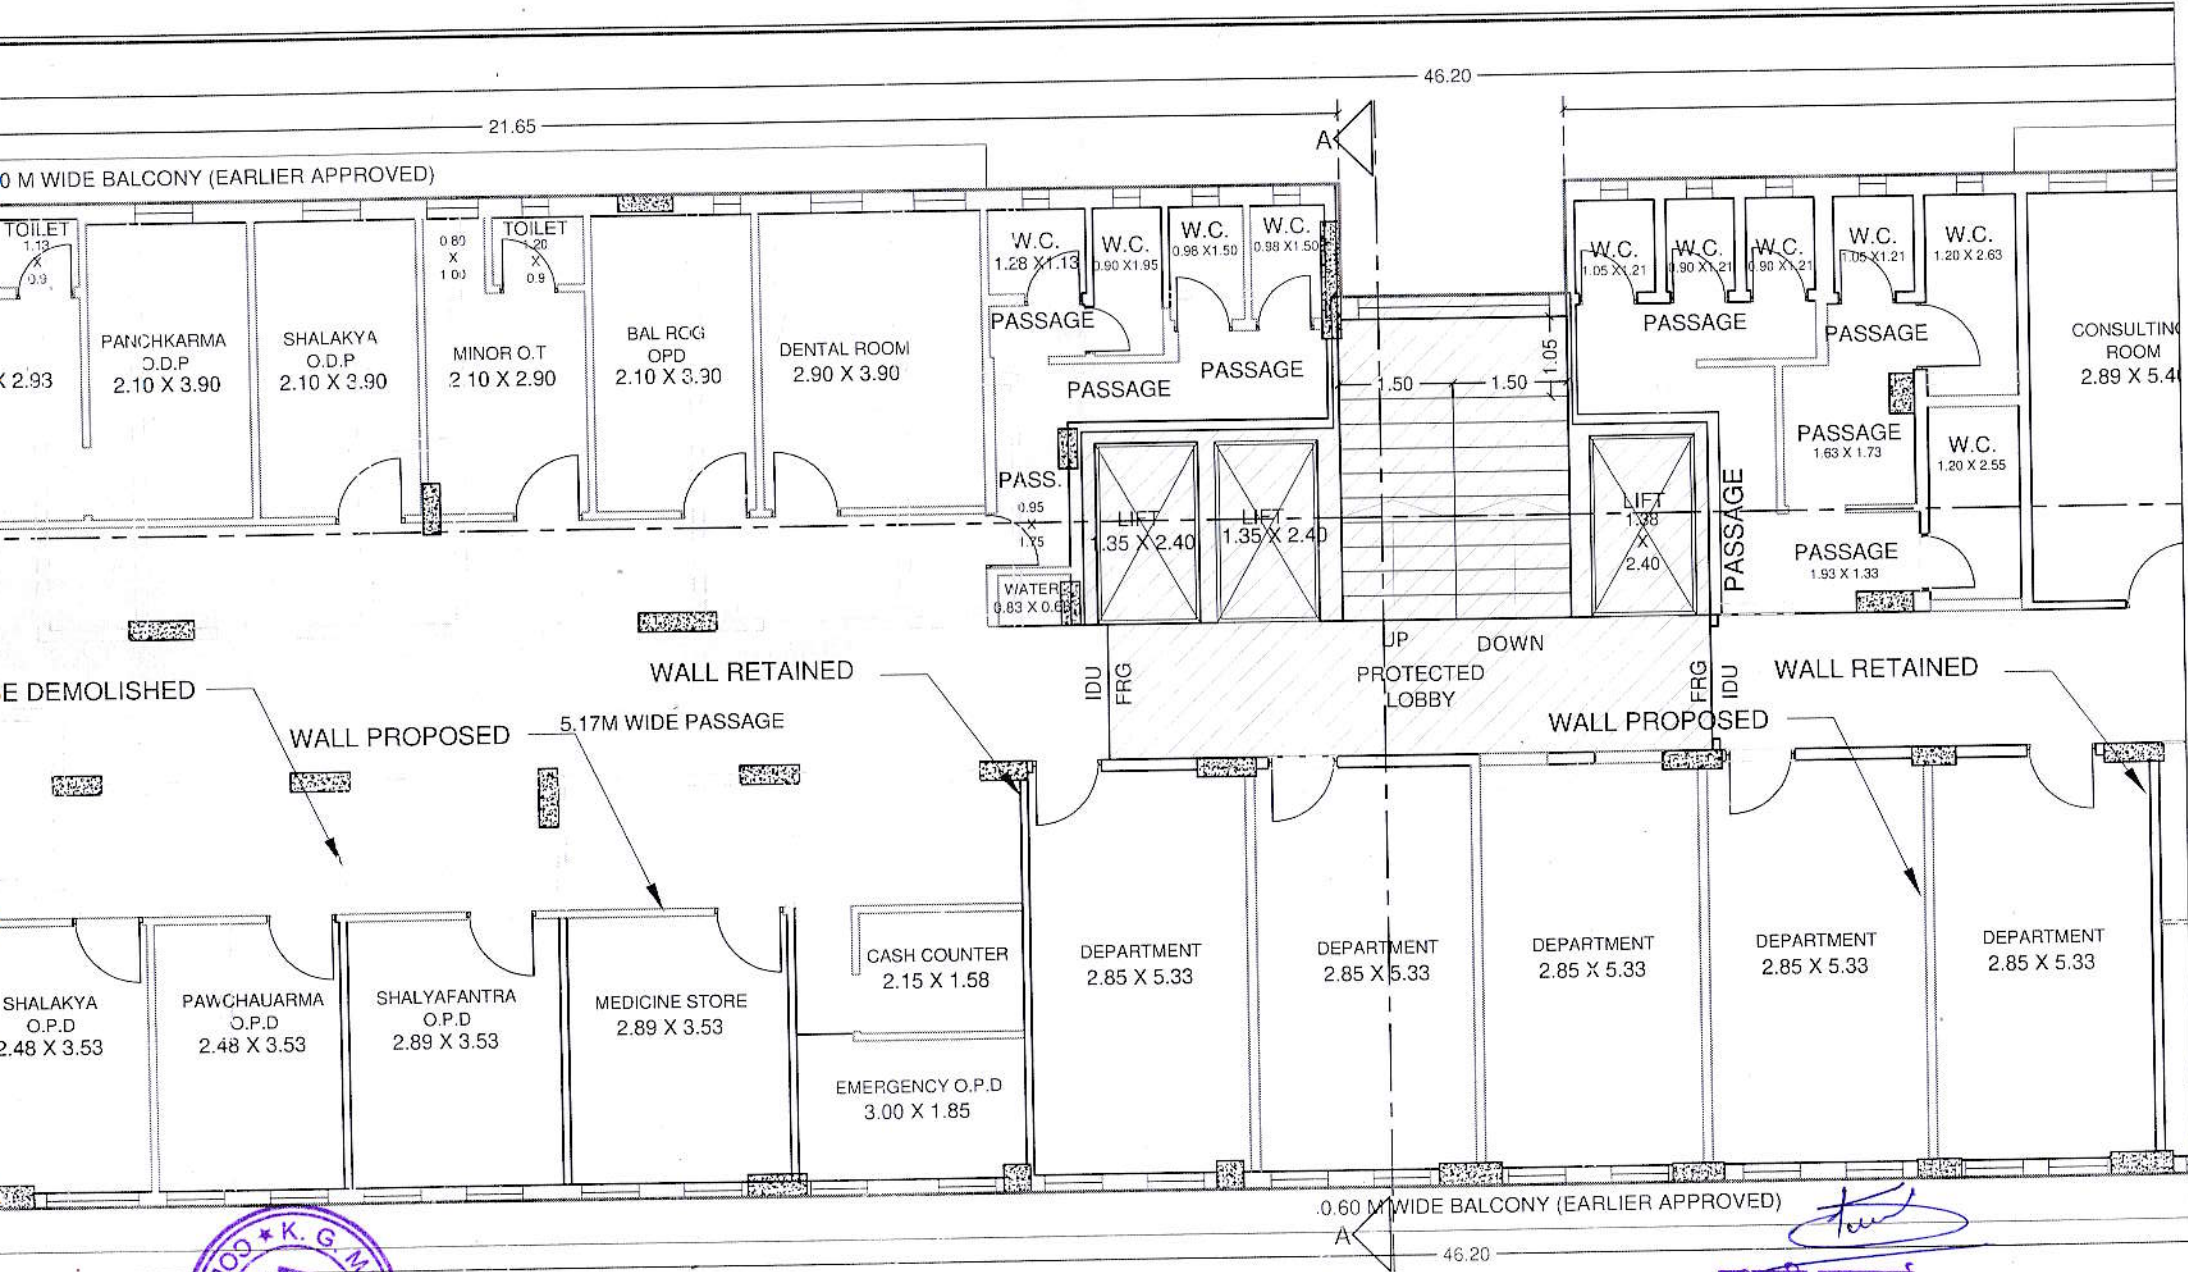

FLOOR PLAN
SCALE 1:100



प्रभारी प्राचार्य
के. जी. मित्तल आयुर्वेद कॉलेज
नेताजी सुभाष रोड, मरीन ड्राईव्ह,
तारापोखला मत्सालय पाठीमागे,
मुंबई - ४०० ००२.

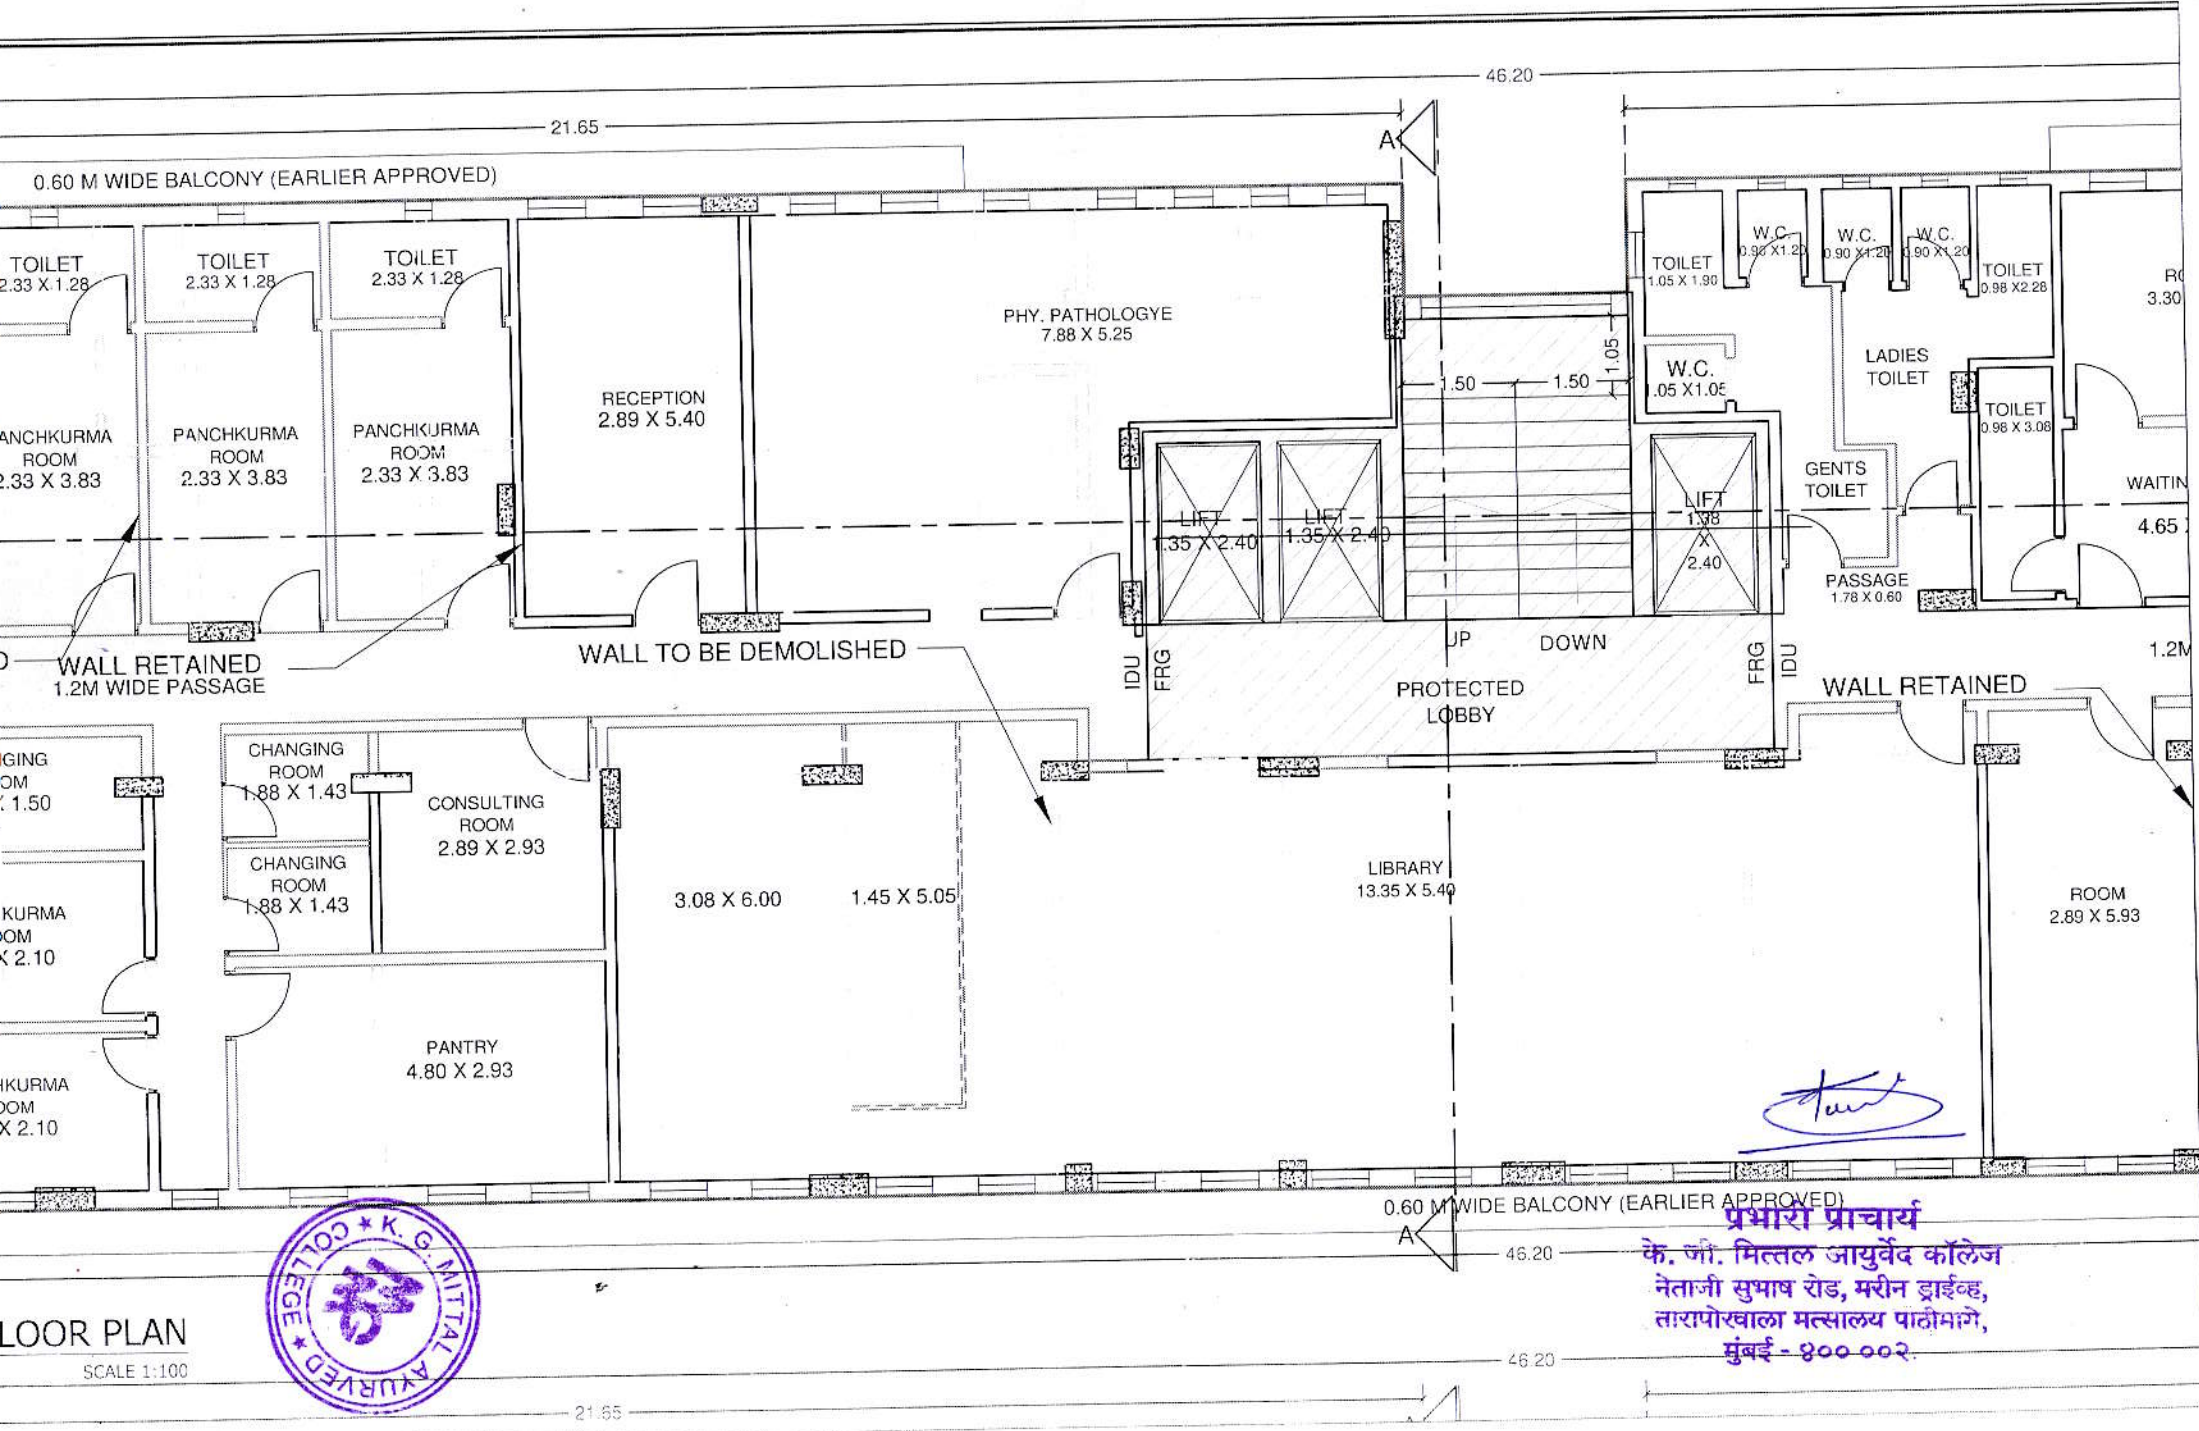

FLOOR PLAN
SCALE 1:100



प्रभारी प्राचार्य
के. जी. मित्तल आयुर्वेद कॉलेज
 नेताजी सुभाष रोड, मरीन ड्राईव्ह,
 तारापोखाला मत्सालय पाठीभागे,
 मुंबई - ४०० ००२.




INCHARGE PRINCIPAL

K. G. Mittal Ayurved College

Netaji Subhash Road, Marine Drive,
Next to Taraporewala Aquarium,

Mumbai - 400 002.

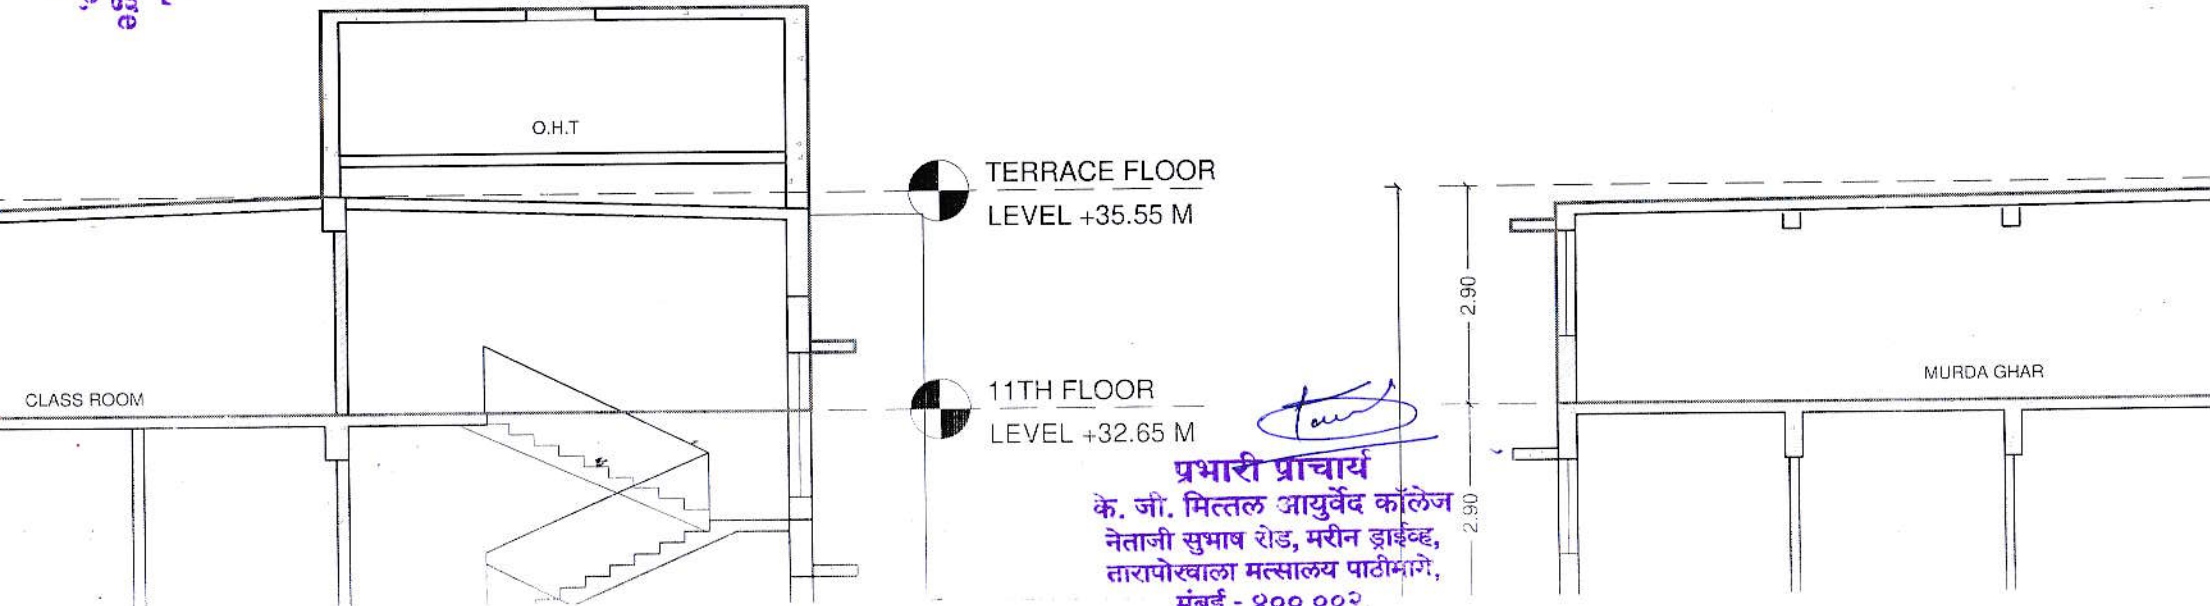

प्रभारी प्राचार्य
के. जी. मित्तल आयुर्वेद कॉलेज
नेताजी सुभाष रोड, मरीन ड्राईव्ह,
तारापोखला मत्सालय पाठीभागे,
मुंबई - ४०० ००२